


Contractors shall verify and be responsible for all field dimensions and conditions and shall notify OAC immediately of any discrepancies before proceeding with the project.




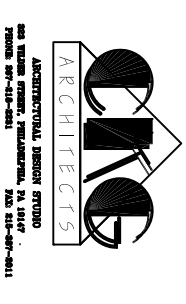


Revisions	Date

TEVEL MANAGEMENT INC.  
4700 CHESTNUT STREET  
PHILADELPHIA, PA

Project # 2014.08  
Scale AS NOTED  
Date JUNE 4, 2014  
Drawn By FCC  
Approved By FCC

Project: 4700 CHESTNUT STREET  
Drawing Title: **SITE PLAN-COUNCIL ORDINANCE**  
Drawing Number: **A001a**

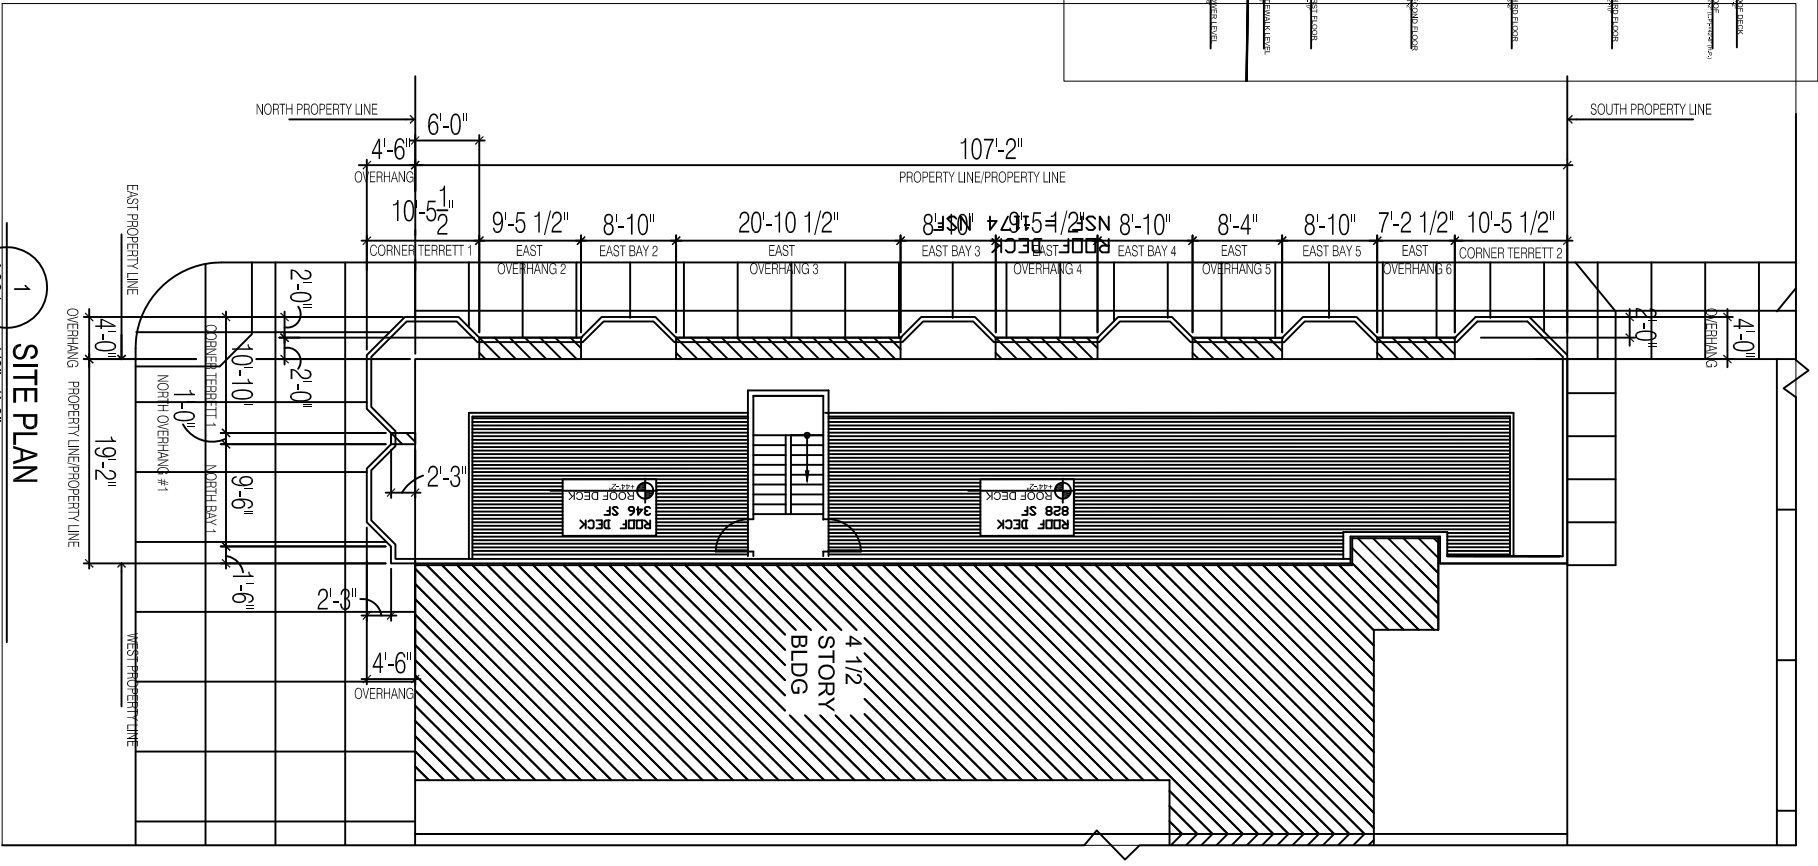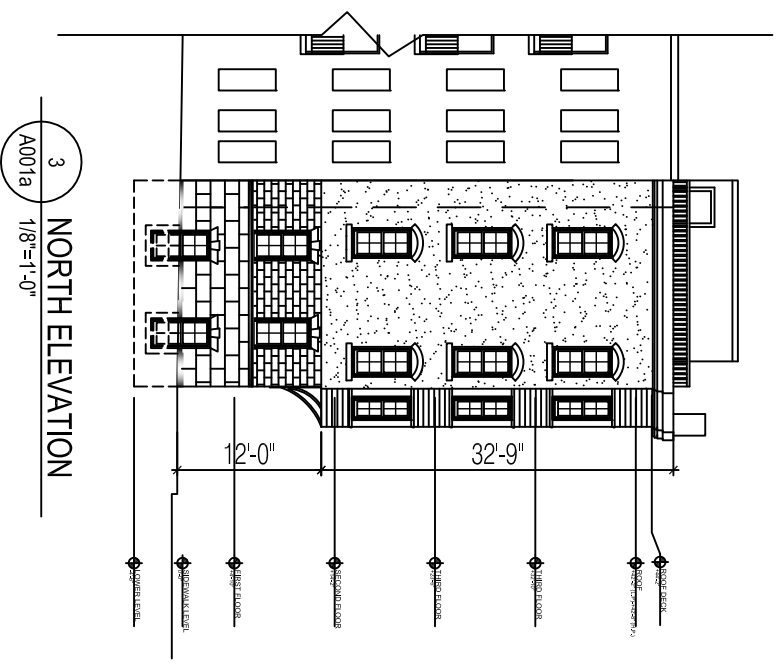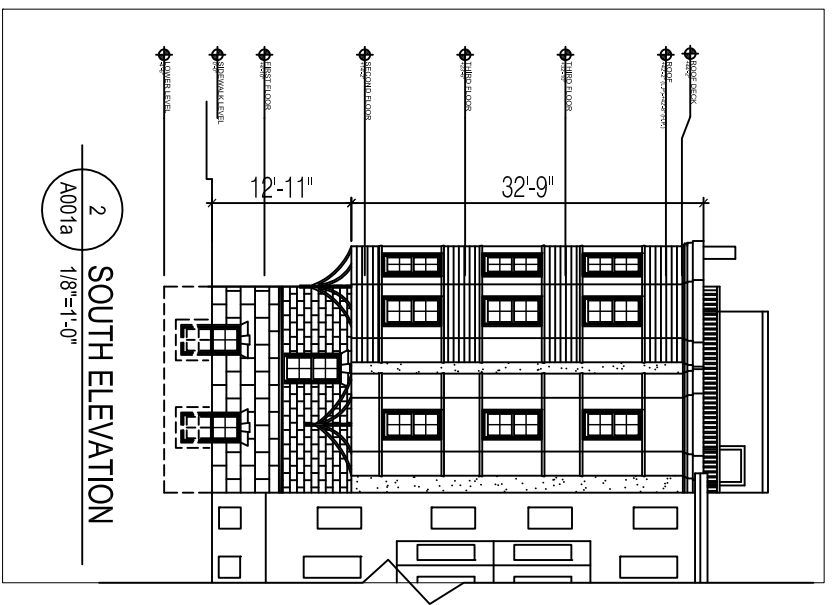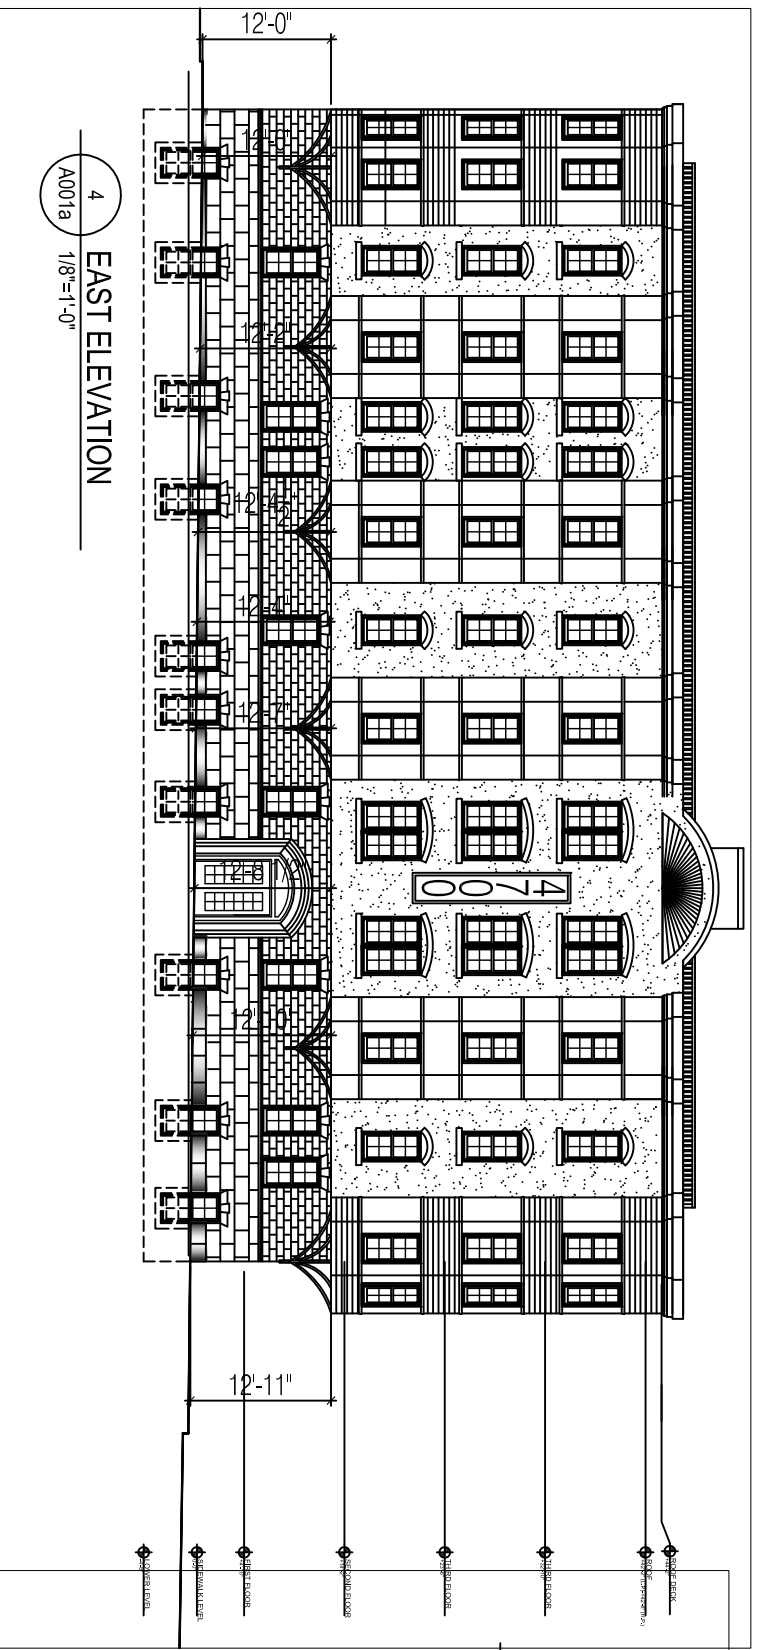

**COUNCIL ORDINANCE DWG. 9-18-15**

**A001a**